



1 Second Floor Reflected Ceiling Plan
3/32" = 1'-0"

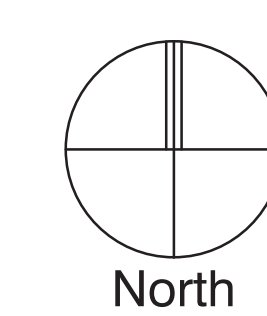

RCP Legend	
Key	Description
[Stippled Box]	Painted Gypsum Board
[Grid Box]	2x2' ceiling grid and ceiling tile
[Circle]	Round Downlight
[Square]	Square Downlight
[Circle with dot]	Pendant Light Fixture
[Square with dot]	Fluorescent Light Fixture
[Circle with cross]	Wall Mounted Light Fixture
[Square with cross]	HVAC Return Air
[Square with dot]	HVAC Supply Air
[Dashed Line]	Symbol for exposed ceiling
[Dotted Line]	Symbol for ceiling height
[Thick Line]	Wall to deck
[Thin Line]	10'-6" High wall with top cap
[Double Line]	Exposed existing ceiling with exposed beams and structure

- Sheet Notes**
1. General Contractor to coordinate the layout for all supply grill locations with mechanical drawings.
 2. General Contractor to coordinate all light locations mechanical ductwork, and sprinkler piping locations prior to installation per the plans.
 3. General Contractor to verify all ceiling heights prior to installation.
 4. General Contractor is responsible for final cleaning of all light fixtures.
 5. Refer to Electrical drawings. RCP reflects fixture layout only.

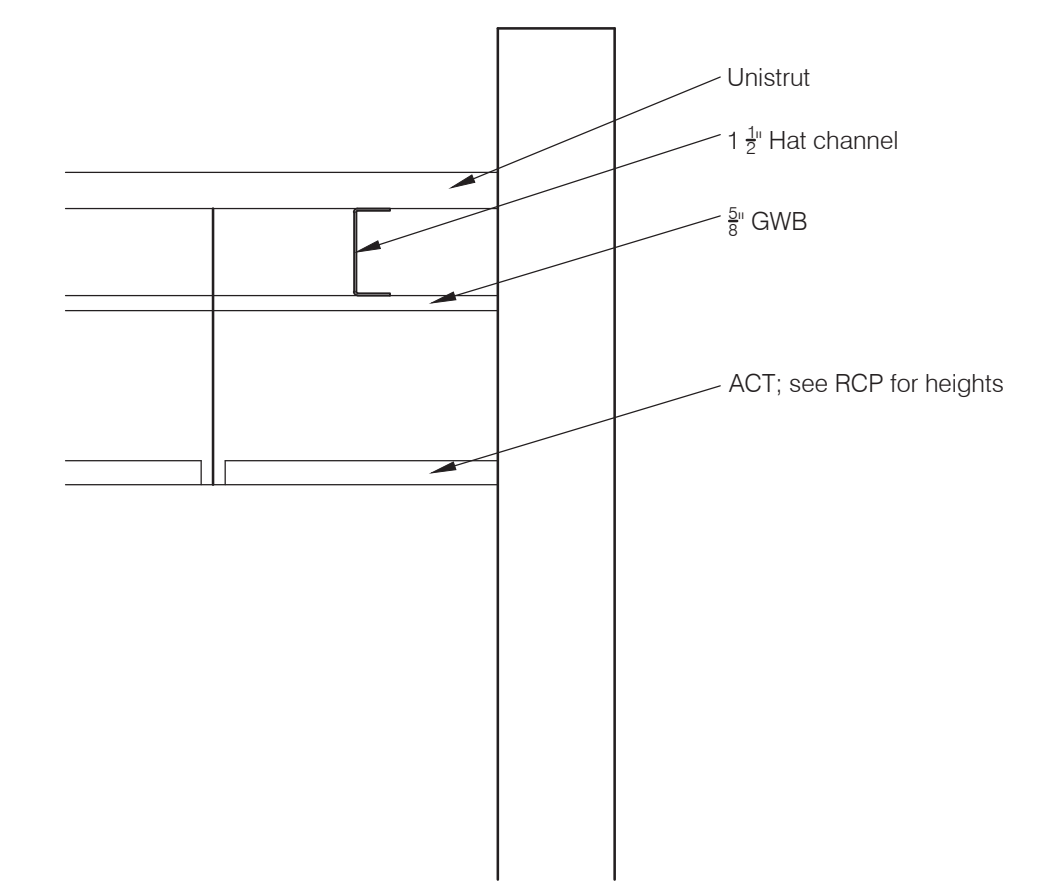

2 Ceiling Detail
1 1/2" = 1'-0"

Project No: 13083
Date: 10 Oct 2014
Drawn By: MBF
Checked:
Revisions:
Revisions:
Revisions: